



| Façade: South         |     |    |
|-----------------------|-----|----|
| Total Square Footage: | 827 |    |
| Classes of Material   | SF  | %  |
| Class I: Brick        | 393 | 48 |
| Class II: Cast Stone  | 81  | 10 |
| Class I: Glass        | 242 | 29 |
| Class II: ACM         | 111 | 13 |

| Façade: East          |      |    |
|-----------------------|------|----|
| Total Square Footage: | 1353 |    |
| Classes of Material   | SF   | %  |
| Class I: Brick        | 893  | 48 |
| Class II: Cast Stone  | 390  | 21 |
| Class I: Glass        | 394  | 21 |
| Class II: ACM         | 176  | 10 |




ANKENY  
2012 SE Delaware Avenue  
Ankeny, IA 50021

## ARCHITECTURAL ELEVATIONS

12.08.2022


Architect/Designer  
The Architects Partnership, Ltd.  
200 South Michigan Avenue  
Chicago, IL 60604  
t: 312.583.9800  
f: 312.583.9890  
TAP Project Number: 22023



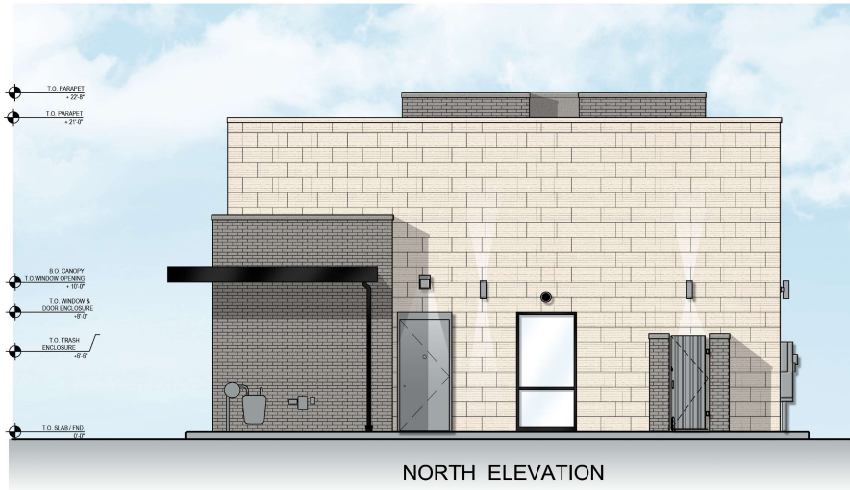

|                            |           |          |
|----------------------------|-----------|----------|
| Façade: North              |           |          |
| Total Square Footage:      | 826       |          |
| <b>Classes of Material</b> | <b>SF</b> | <b>%</b> |
| Class I: Brick             | 205       | 24       |
| Class II: Cast Stone       | 527       | 64       |
| Class I: Glass             | 28        | 4        |
| Class II: ACM              | 66        | 8        |

|                            |           |          |
|----------------------------|-----------|----------|
| Façade: West               |           |          |
| Total Square Footage:      | 1834      |          |
| <b>Classes of Material</b> | <b>SF</b> | <b>%</b> |
| Class I: Brick             | 825       | 45       |
| Class II: Cast Stone       | 515       | 28       |
| Class I: Glass             | 340       | 19       |
| Class II: ACM              | 154       | 8        |

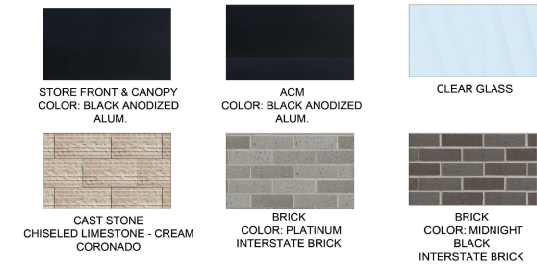

**ANKENY**  
2012 SE Delaware Avenue  
Ankeny, IA 50021

## ARCHITECTURAL ELEVATIONS

12.08.2022

Architect/Designer  
The Architects Partnership, Ltd.  
200 South Michigan Avenue  
Chicago, IL 60604  
t: 312.583.9800  
f: 312.583.9890  
TAP Project Number: 22023





**ANKENY**  
2012 SE Delaware Avenue,  
Ankeny, IA 50021

## ARCHITECTURAL ELEVATIONS

01.20.2023

Architect/Designer  
The Architects Partnership, Ltd.  
200 South Michigan Avenue  
Chicago, IL 60604  
t: 312.583.9800  
f: 312.583.9890  
TAP Project Number: 22023






| EXTERIOR FINISH MATERIALS |                                                                                      |
|---------------------------|--------------------------------------------------------------------------------------|
| ST-3                      | <b>CAST STONE BROOMFACE (S.L.S. CAPS, ETC.) WITH REVELED TOP FACE AND CHIP CUT</b>   |
|                           | MANUFACTURER HARVEY CEMENT PRODUCTS INC. (OR APPROVED EQUAL)                         |
|                           | PRODUCT SAVANNA STONE                                                                |
|                           | COLOR MATCH ADJACENT MATERIAL                                                        |
|                           | FINISH SMOOTH                                                                        |
|                           | SIZE 24" WIDE x 4" HIGH x DEPTH AS REQD. OR SHOWN IN DETAILS WITH BROOM AND CHIP CUT |
| ST-4                      | <b>CAST STONE, ROCKFACE (FIELD UNITS)</b>                                            |
|                           | MANUFACTURER COLORADO STONE PRODUCTS                                                 |
|                           | PRODUCT MANUFACTURED STONE VENEER                                                    |
|                           | COLOR CREAM                                                                          |
|                           | FINISH CHISELED LIMESTONE                                                            |
|                           | SIZE 24" WIDE x 12" HIGH x 7" THICK                                                  |
|                           | <b>PORTLAND CEMENT GROUT TO MATCH STONE COLOR</b>                                    |
|                           | MANUFACTURER HARVEY CEMENT PRODUCTS INC.                                             |
|                           | PRODUCT PORTLAND CEMENT GROUT                                                        |
|                           | COLOR MATCH STONE COLOR                                                              |
|                           | FINISH SMOOTH                                                                        |
|                           | SIZE 1/2" DEEP NOMINAL (S.L.S.)                                                      |


|      |                                                           |
|------|-----------------------------------------------------------|
| BR-1 | <b>INTERSTATE BRICK COMPANY (OR APPROVED EQUAL)</b>       |
|      | MANUFACTURER INTERSTATE BRICK COMPANY (OR APPROVED EQUAL) |
|      | PRODUCT 2-1/4" MODULAR COMMERCIAL                         |
|      | COLOR PLATINUM                                            |
|      | FINISH SMOOTH                                             |
|      | SIZE 2-1/4" MODULAR (S.L.S.)                              |
| BR-2 | <b>INTERSTATE BRICK COMPANY (OR APPROVED EQUAL)</b>       |
|      | MANUFACTURER INTERSTATE BRICK COMPANY (OR APPROVED EQUAL) |
|      | PRODUCT 2-1/4" MODULAR COMMERCIAL                         |
|      | COLOR MIDNIGHT BLACK                                      |
|      | FINISH SMOOTH                                             |
|      | SIZE 2-1/4" MODULAR (S.L.S.)                              |
| RC-1 | <b>PETERSEN ALUMINUM (PAC-CLAD)</b>                       |
|      | MANUFACTURER PETERSEN ALUMINUM (PAC-CLAD)                 |
|      | PRODUCT PAC-CONTINUOUS                                    |
|      | COLOR SANDSTONE                                           |
|      | FINISH SMOOTH                                             |
|      | SIZE 2-1/4" MODULAR (S.L.S.)                              |
| RC-2 | <b>PETERSEN ALUMINUM (PAC-CLAD)</b>                       |
|      | MANUFACTURER PETERSEN ALUMINUM (PAC-CLAD)                 |
|      | PRODUCT PAC-CONTINUOUS                                    |
|      | COLOR CUSTOM                                              |
|      | FINISH SMOOTH                                             |
|      | SIZE 2-1/4" MODULAR (S.L.S.)                              |

|       |                                                    |
|-------|----------------------------------------------------|
| RC-3  | <b>PETERSEN ALUMINUM (PAC-CLAD)</b>                |
|       | MANUFACTURER PETERSEN ALUMINUM (PAC-CLAD)          |
|       | PRODUCT PAC-CONTINUOUS                             |
|       | COLOR TO MATCH BR-2                                |
|       | FINISH SMOOTH                                      |
|       | SIZE 2-1/4" MODULAR (S.L.S.)                       |
| ACB-1 | <b>ALUMINUM COMPOSITE MATERIAL</b>                 |
|       | MANUFACTURER ALUMA ARCHITECTURAL PRODUCTS          |
|       | PRODUCT REYNOLDS                                   |
|       | COLOR DURALGLOSS 9000 CHASE PROGRAM "CHASE QUARTZ" |
|       | FINISH SMOOTH                                      |
|       | SIZE 2-1/4" MODULAR (S.L.S.)                       |
| EPF-1 | <b>SHERWIN-WILLIAMS</b>                            |
|       | MANUFACTURER SHERWIN-WILLIAMS                      |
|       | PRODUCT METALUXE WATER SEMI-GLOSS                  |
|       | COLOR SW 7068 INTELLECTUAL GRAY                    |
|       | FINISH SEMI-GLOSS                                  |
|       | SIZE 2-1/4" MODULAR (S.L.S.)                       |
| EPF-2 | <b>SHERWIN-WILLIAMS</b>                            |
|       | MANUFACTURER SHERWIN-WILLIAMS                      |
|       | PRODUCT METALUXE WATER SEMI-GLOSS                  |
|       | COLOR SW 7068 INTELLECTUAL GRAY                    |
|       | FINISH SEMI-GLOSS                                  |
|       | SIZE 2-1/4" MODULAR (S.L.S.)                       |

| ELEVATION GENERAL NOTES |                                                                                                                                                                                                                     |
|-------------------------|---------------------------------------------------------------------------------------------------------------------------------------------------------------------------------------------------------------------|
| 1                       | NOT ALL KEYNOTES ARE USED BY PROJECT                                                                                                                                                                                |
| 2                       | AT 16' DOOR CASE STONE CORNERS UTILIZE 1" SHAPED CAST STONE IN PLACE OF METRIC CORNERS.                                                                                                                             |
| 3                       | SEE SHEET A2.2 FOR WINDOW SCHEDULE                                                                                                                                                                                  |
| 4                       | PROVIDE MAINTENANCE SEALER/GROUT CONTROL ON ALL MASONRY SURFACES FROM GRADE TO TOP OF FINISH. MIN. 4" AFF.                                                                                                          |
| ELEVATION NOTES         |                                                                                                                                                                                                                     |
| EE-01                   | CONCRETE FOOTINGS/FOUNDATIONS REFER TO STRUCTURAL UNITS.                                                                                                                                                            |
| EE-02                   | CONCRETE CURB AND SLABS REFER TO ARCHITECTURAL SITE PLAN AND DRIVE UP CANOPY PLAN.                                                                                                                                  |
| EE-03                   | EMERGENCY ACCESS KEY BOX: WHEN PROVIDED BY LOCAL CODE ONLY, ACCESS/KEYBOX SHALL BE LOCATED AS REQD. TO SET FACE FLUSH WITH ADJACENT WALL. FINISH VERIFY FINAL LOCATION WITH AUTHORITY HAVING JURISDICTION.          |
| EE-04                   | LIGHTING TIMER SYSTEM PHOTO SENSOR REFER TO ELECTRICAL DRAWINGS.                                                                                                                                                    |
| EE-05                   | IRRIGATION SYSTEM PHOTO SENSOR REFER TO ELECTRICAL DRAWINGS.                                                                                                                                                        |
| EE-06                   | IRRIGATION SYSTEM CONTROL BOX.                                                                                                                                                                                      |
| EE-07                   | ENTRANCE CANOPY (BY GC): SHIP FABRICATED AND ANCHORED CUSTOM ALUMINUM RAIL WITH INTEGRAL ELECTRICAL & DRAINAGE SYSTEMS FASTENED TO BUILDING STRUCTURE. REFER TO ROCK PLAN & WALL SECTION.                           |
| EE-08                   | CONTROL EXPANSION JOINT: VERTICAL EXPANSION JOINT CONTINGUOUS THROUGH VENEER. MATCH STONE COLOR TO VENEER COLOR. ALSO PLACE CONTROL JOINTS AT EACH INSIDE CORNER AND SHAPINGLY INDICATED.                           |
| EE-09                   | SUN SHADE: GLASS SYSTEM MANUFACTURER'S STANDARD INTEGRAL SHADE ACCESSORY. REFER TO WALL SECTION. MATCH GLASS SYSTEM FINISH.                                                                                         |
| EE-10                   | CORNER: REFER TO ROCK PLAN.                                                                                                                                                                                         |
| EE-11                   | SMALL CANOPY DOWNPOUT: FINAL ALUMINUM DOWNPOUT FINISH TO MATCH CANOPY CORNER TO CAST IRON DOWNPOUT AT CORNER AND EXTEND SUBSURFACE TO SITE DRAINAGE SYSTEM. REFER TO ROCK PLAN AND CAN.                             |
| EE-12                   | SCUPPER: REFER TO ROCK PLAN AND DETAILS.                                                                                                                                                                            |
| EE-13                   | DOWNPOUT RAIL: WITH INTEGRAL DRAINAGE SYSTEM. REFER TO PLUMBING DRAWINGS AND PLUMBING FUTURE SCHEDULE ON ELECTRICAL DRAWINGS.                                                                                       |
| EE-14                   | SURFACE MOUNTED EMERGENCY LIGHT FIXTURE: REFER TO ELECTRICAL DRAWINGS FOR LIGHT FIXTURE SCHEDULE ON ELECTRICAL DRAWINGS.                                                                                            |
| EE-15                   | AUTOMATIC DOOR OPERATOR BUTTON AND KEYPAD: READY PRESSED FLUSH WITH WALL SURFACE. DO NOT SURFACE MOUNT. REFER TO DETAIL SH-2A.                                                                                      |
| EE-16                   | SECURITY CAMERA: REFER TO ELECTRICAL DRAWINGS.                                                                                                                                                                      |
| EE-17                   | STONE CORNER: REFER TO DETAILS SHEET A2.2.                                                                                                                                                                          |
| EE-18                   | PHOTOVOLTAIC SYSTEM FUSED DISCONNECT SWITCH: REFER TO ELECTRICAL DRAWINGS.                                                                                                                                          |
| EE-19                   | ROLLUP: CONCRETE ROLLUP STEEL PIPE EMBEDDED IN CONCRETE CURB WITH PLASTIC COVER. REFER TO SITE PLAN. DRIVE UP CANOPY PLAN AND DETAIL SH-2. ANY EXISTING NOT ADJACENT TO VEHICULAR LANE (LANDSCAPE, WALK, ETC.).     |
| EE-20                   | MAINTENANCE CONTROL, LIGHT, SEALANT COLOR TO MATCH MATERIAL SH-4.                                                                                                                                                   |
| EE-21                   | DOORWAY: BY OWNER'S SIGN VENDOR ALL - PROVIDE ROUGH ELEC. HOLES AND BLOCKING IN WALL AS REQD. FOR VENDOR INSTALLATION.                                                                                              |
| EE-22                   | BUILDING ADDRESS NUMBER: WHITE VINYL NUMBERS WITH 1/2" HIDE STROKE APPLIED TO INTERIOR FACE OF GLASS FINISH OR 1/2" HIDE STROKE OR AS REQD. BY LOCAL CODE. PROVIDED BY GC.                                          |
| EE-23                   | LIGHT FIXTURE: REFER TO LIGHT FIXTURE SCHEDULE.                                                                                                                                                                     |
| EE-24                   | HOSE BIB: SET ALIGN WITH FACE OF MASONRY VENEER. REFER TO PLUMBING FUTURE SCHEDULE. S.C. TO PAINT TO MATCH ADJACENT EXTERIOR MATERIAL.                                                                              |
| EE-25                   | ELECTRICAL OUTLET: SET ALIGN WITH FACE OF MASONRY VENEER. PROVIDE METAL COVER COMPLIANT WITH NEC. S.C. TO PAINT TO MATCH ADJACENT EXTERIOR MATERIAL.                                                                |
| EE-26                   | FUTURE PHOTOVOLTAIC SYSTEM DISCONNECT SWITCH AND PERFORMANCE METER: REFER TO ELECTRICAL DRAWINGS.                                                                                                                   |
| EE-27                   | RAIN WATER: S.C. TO PAINT SURFACE MOUNTED EQUIPMENT TO MATCH ADJACENT EXTERIOR MATERIAL.                                                                                                                            |
| EE-28                   | ELECTRICAL SERVICE C.T. METER CABINET: S.C. TO PAINT TO MATCH ADJACENT EXTERIOR MATERIAL.                                                                                                                           |
| EE-29                   | FIRE ALARM SYSTEM BELL AND STROBE: WHEN PROVIDED BY LOCAL CODE ONLY - VERIFY FINAL LOCATION WITH LOCAL AUTHORITY HAVING JURISDICTION.                                                                               |
| EE-30                   | DRAINAGE CONNECTION: FIRE SUPPRESSION SYSTEM EXTERIOR CONNECTION WHEN REQD. BY LOCAL CODE ONLY - VERIFY FINAL LOCATION WITH LOCAL AUTHORITY HAVING JURISDICTION. S.C. TO PAINT TO MATCH ADJACENT EXTERIOR MATERIAL. |
| EE-31                   | TELEPHONE/UTILITY CONNECTION: COORDINATE FINAL LOCATION WITH CABLE ENGINEER. S.C. TO PAINT TO MATCH ADJACENT EXTERIOR MATERIAL.                                                                                     |
| EE-32                   | LANDSCAPE IRRIGATION SYSTEM: CONTROLLER, WIRED/LESS NETWORK CONNECTOR, AND SENSATOR MP POWER OUTLET. S.C. TO PAINT TO MATCH ADJACENT EXTERIOR MATERIAL.                                                             |
| EE-33                   | HORIZONTAL ALUMINUM PANEL JOINT: ALUM WITH C.C. OF MILLION BE SELF-ADJACENT. U/L/D.                                                                                                                                 |
| EE-34                   | DRIVE UP ATM: FURNISHED AND INSTALLED BY BANK EQUIPMENT VENDOR.                                                                                                                                                     |

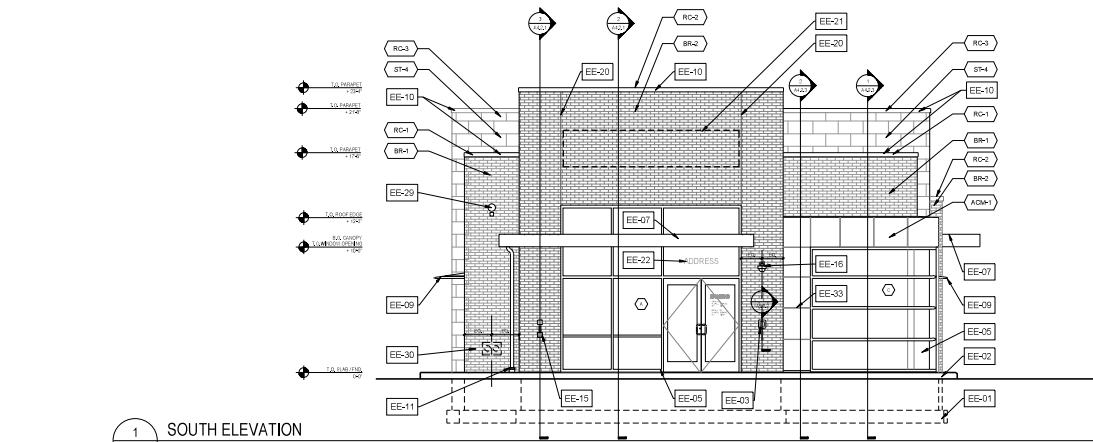

1 SOUTH ELEVATION  
1/8" = 1'-0"

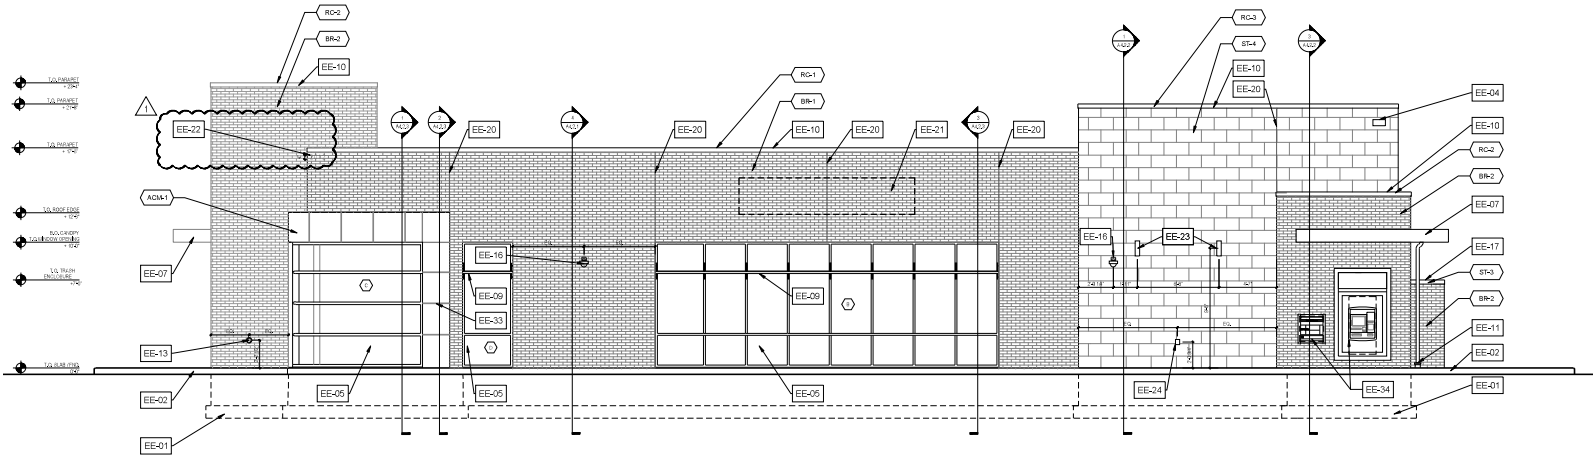

2 EAST ELEVATION  
1/8" = 1'-0"

**CHASE**

**ANKENY**  
RETAIL BANKING CENTER  
2010 SE DELAWARE AVE  
ANKENY, IA 50021

ARCHITECT/ENGINEER OF RECORD

**tap**  
The Architects Partnership



EXPIRES 06/30/2024

| DATE       | DESCRIPTION       |
|------------|-------------------|
| 01/24/2024 | ISSUE FOR PERMITS |
| 02/24/2024 | PERMITS           |

PROJECT INFORMATION BLOCK  
JOB #  
DRAWN BY  
CHECKED BY

SHEET TITLE

EXTERIOR ELEVATIONS

SHEET NUMBER

A2.1